



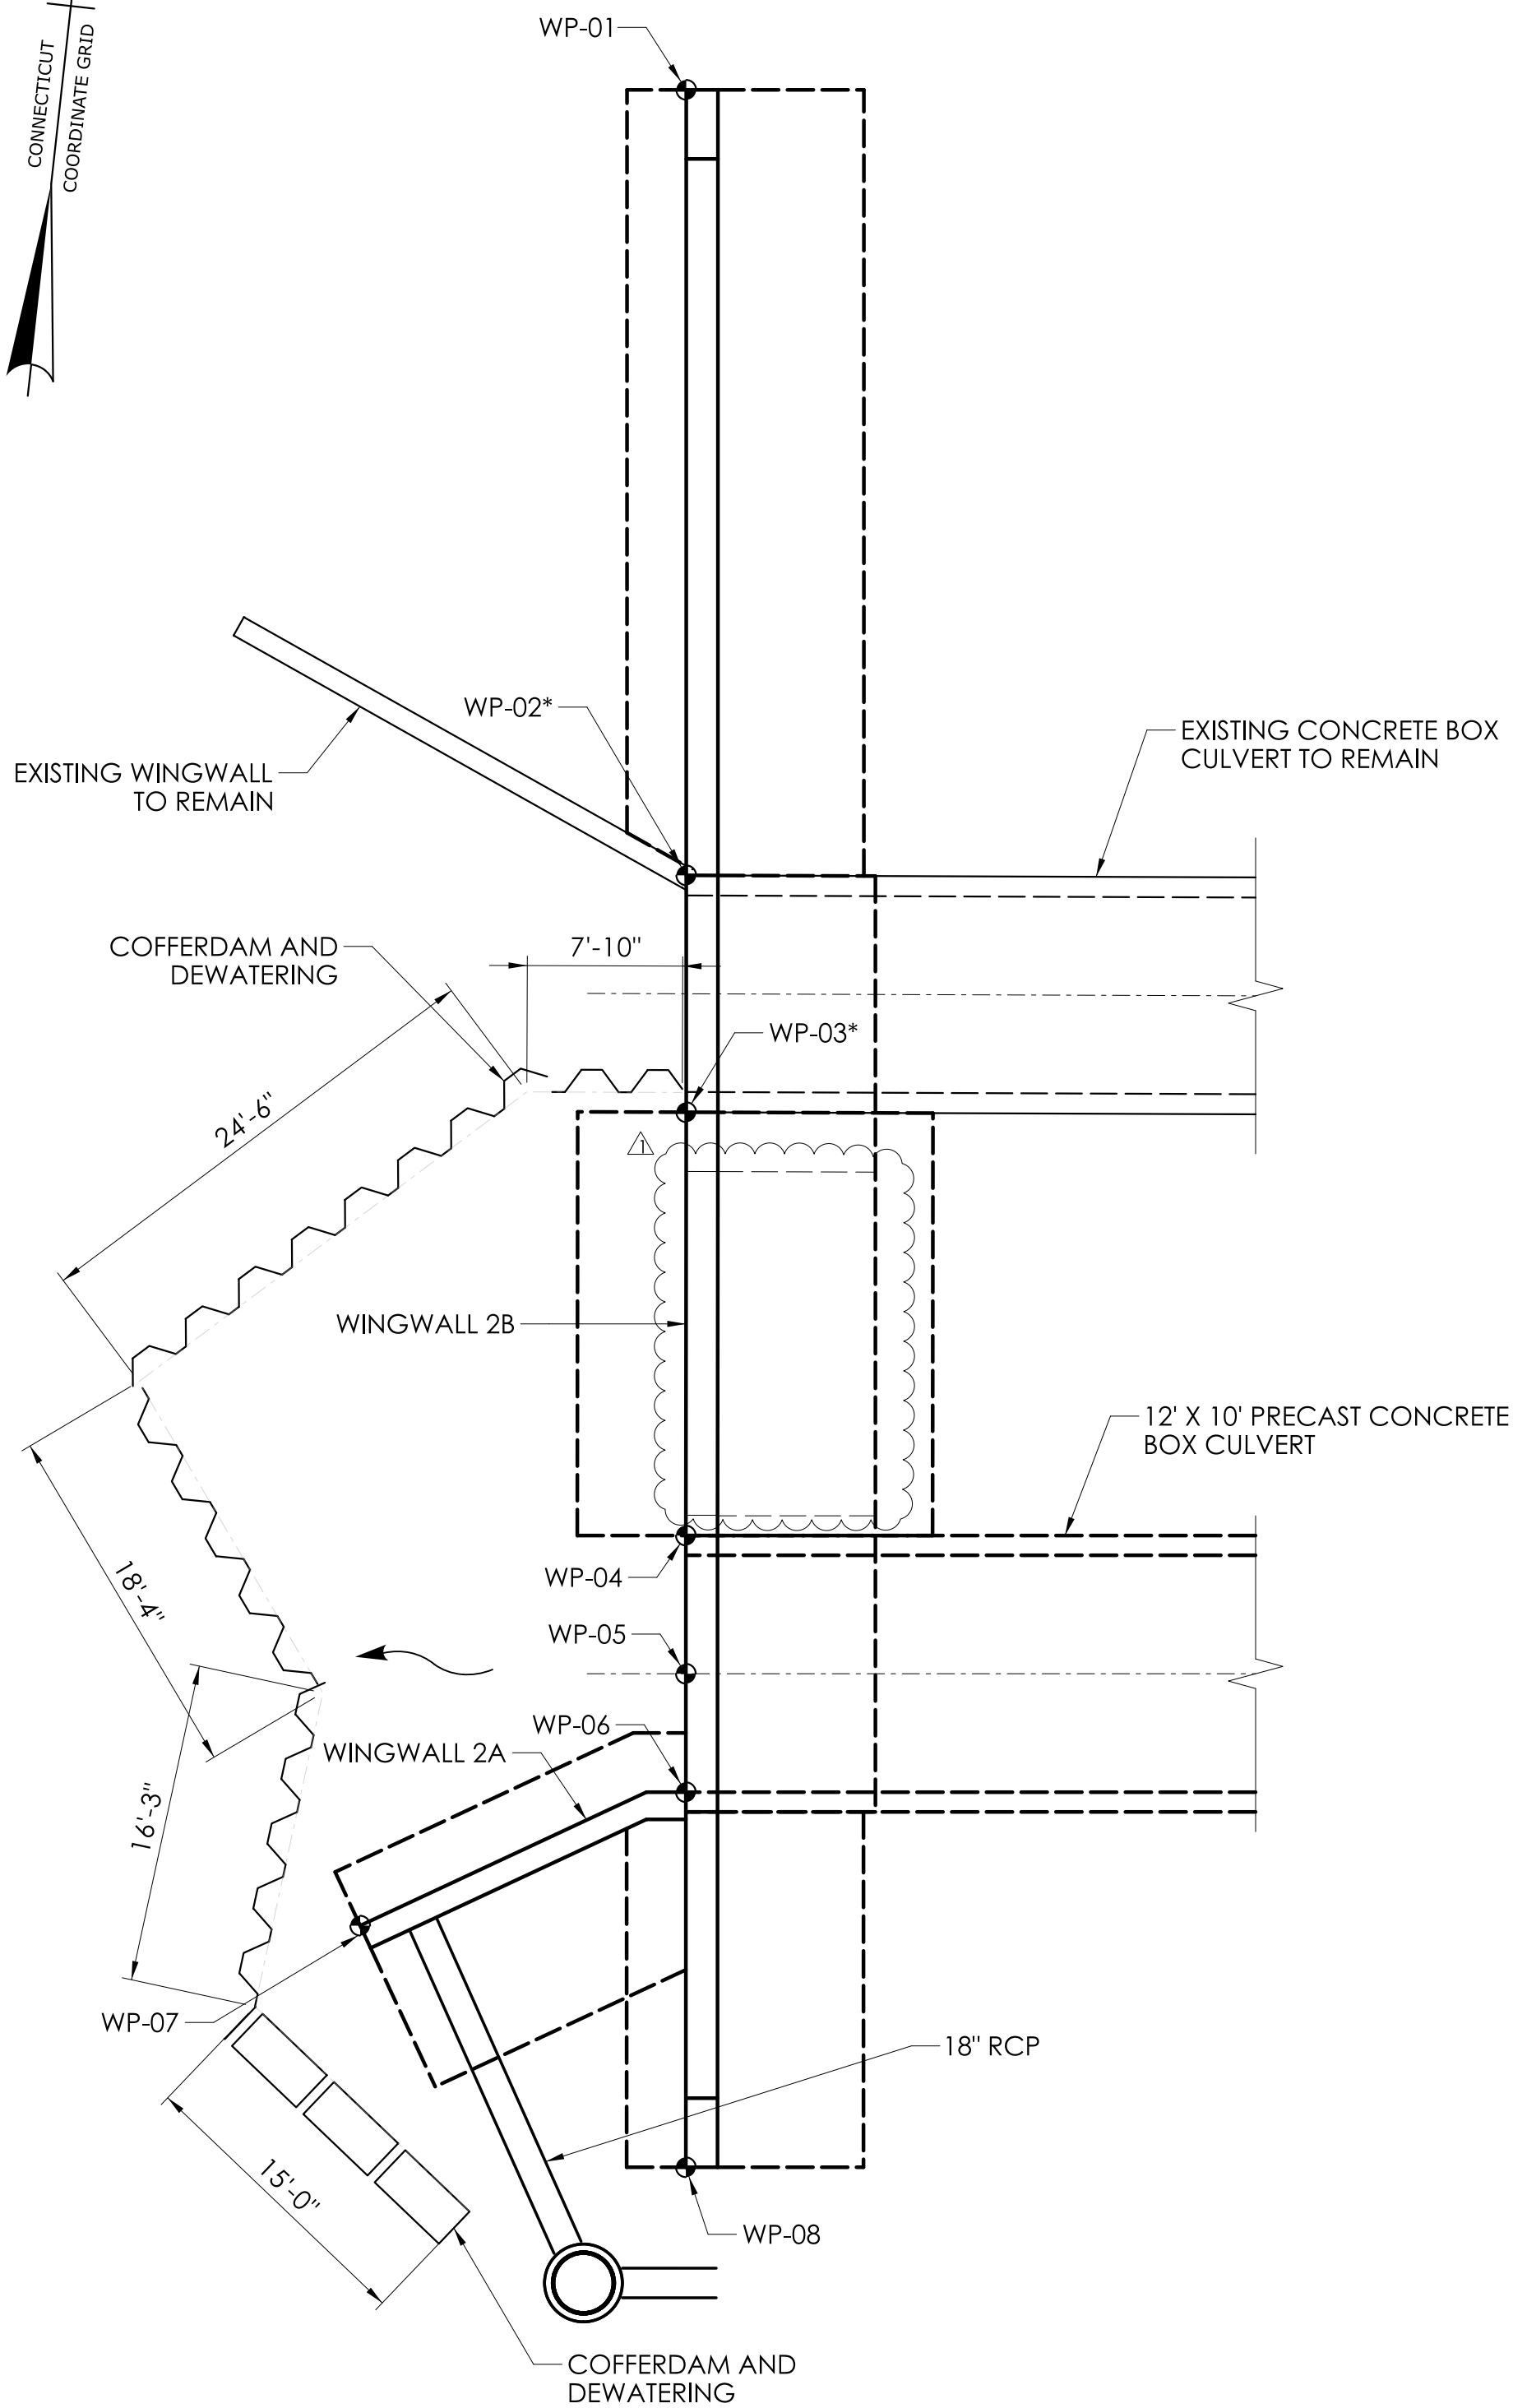

LAYOUT PLAN
SCALE: 1/8" = 1'-0"

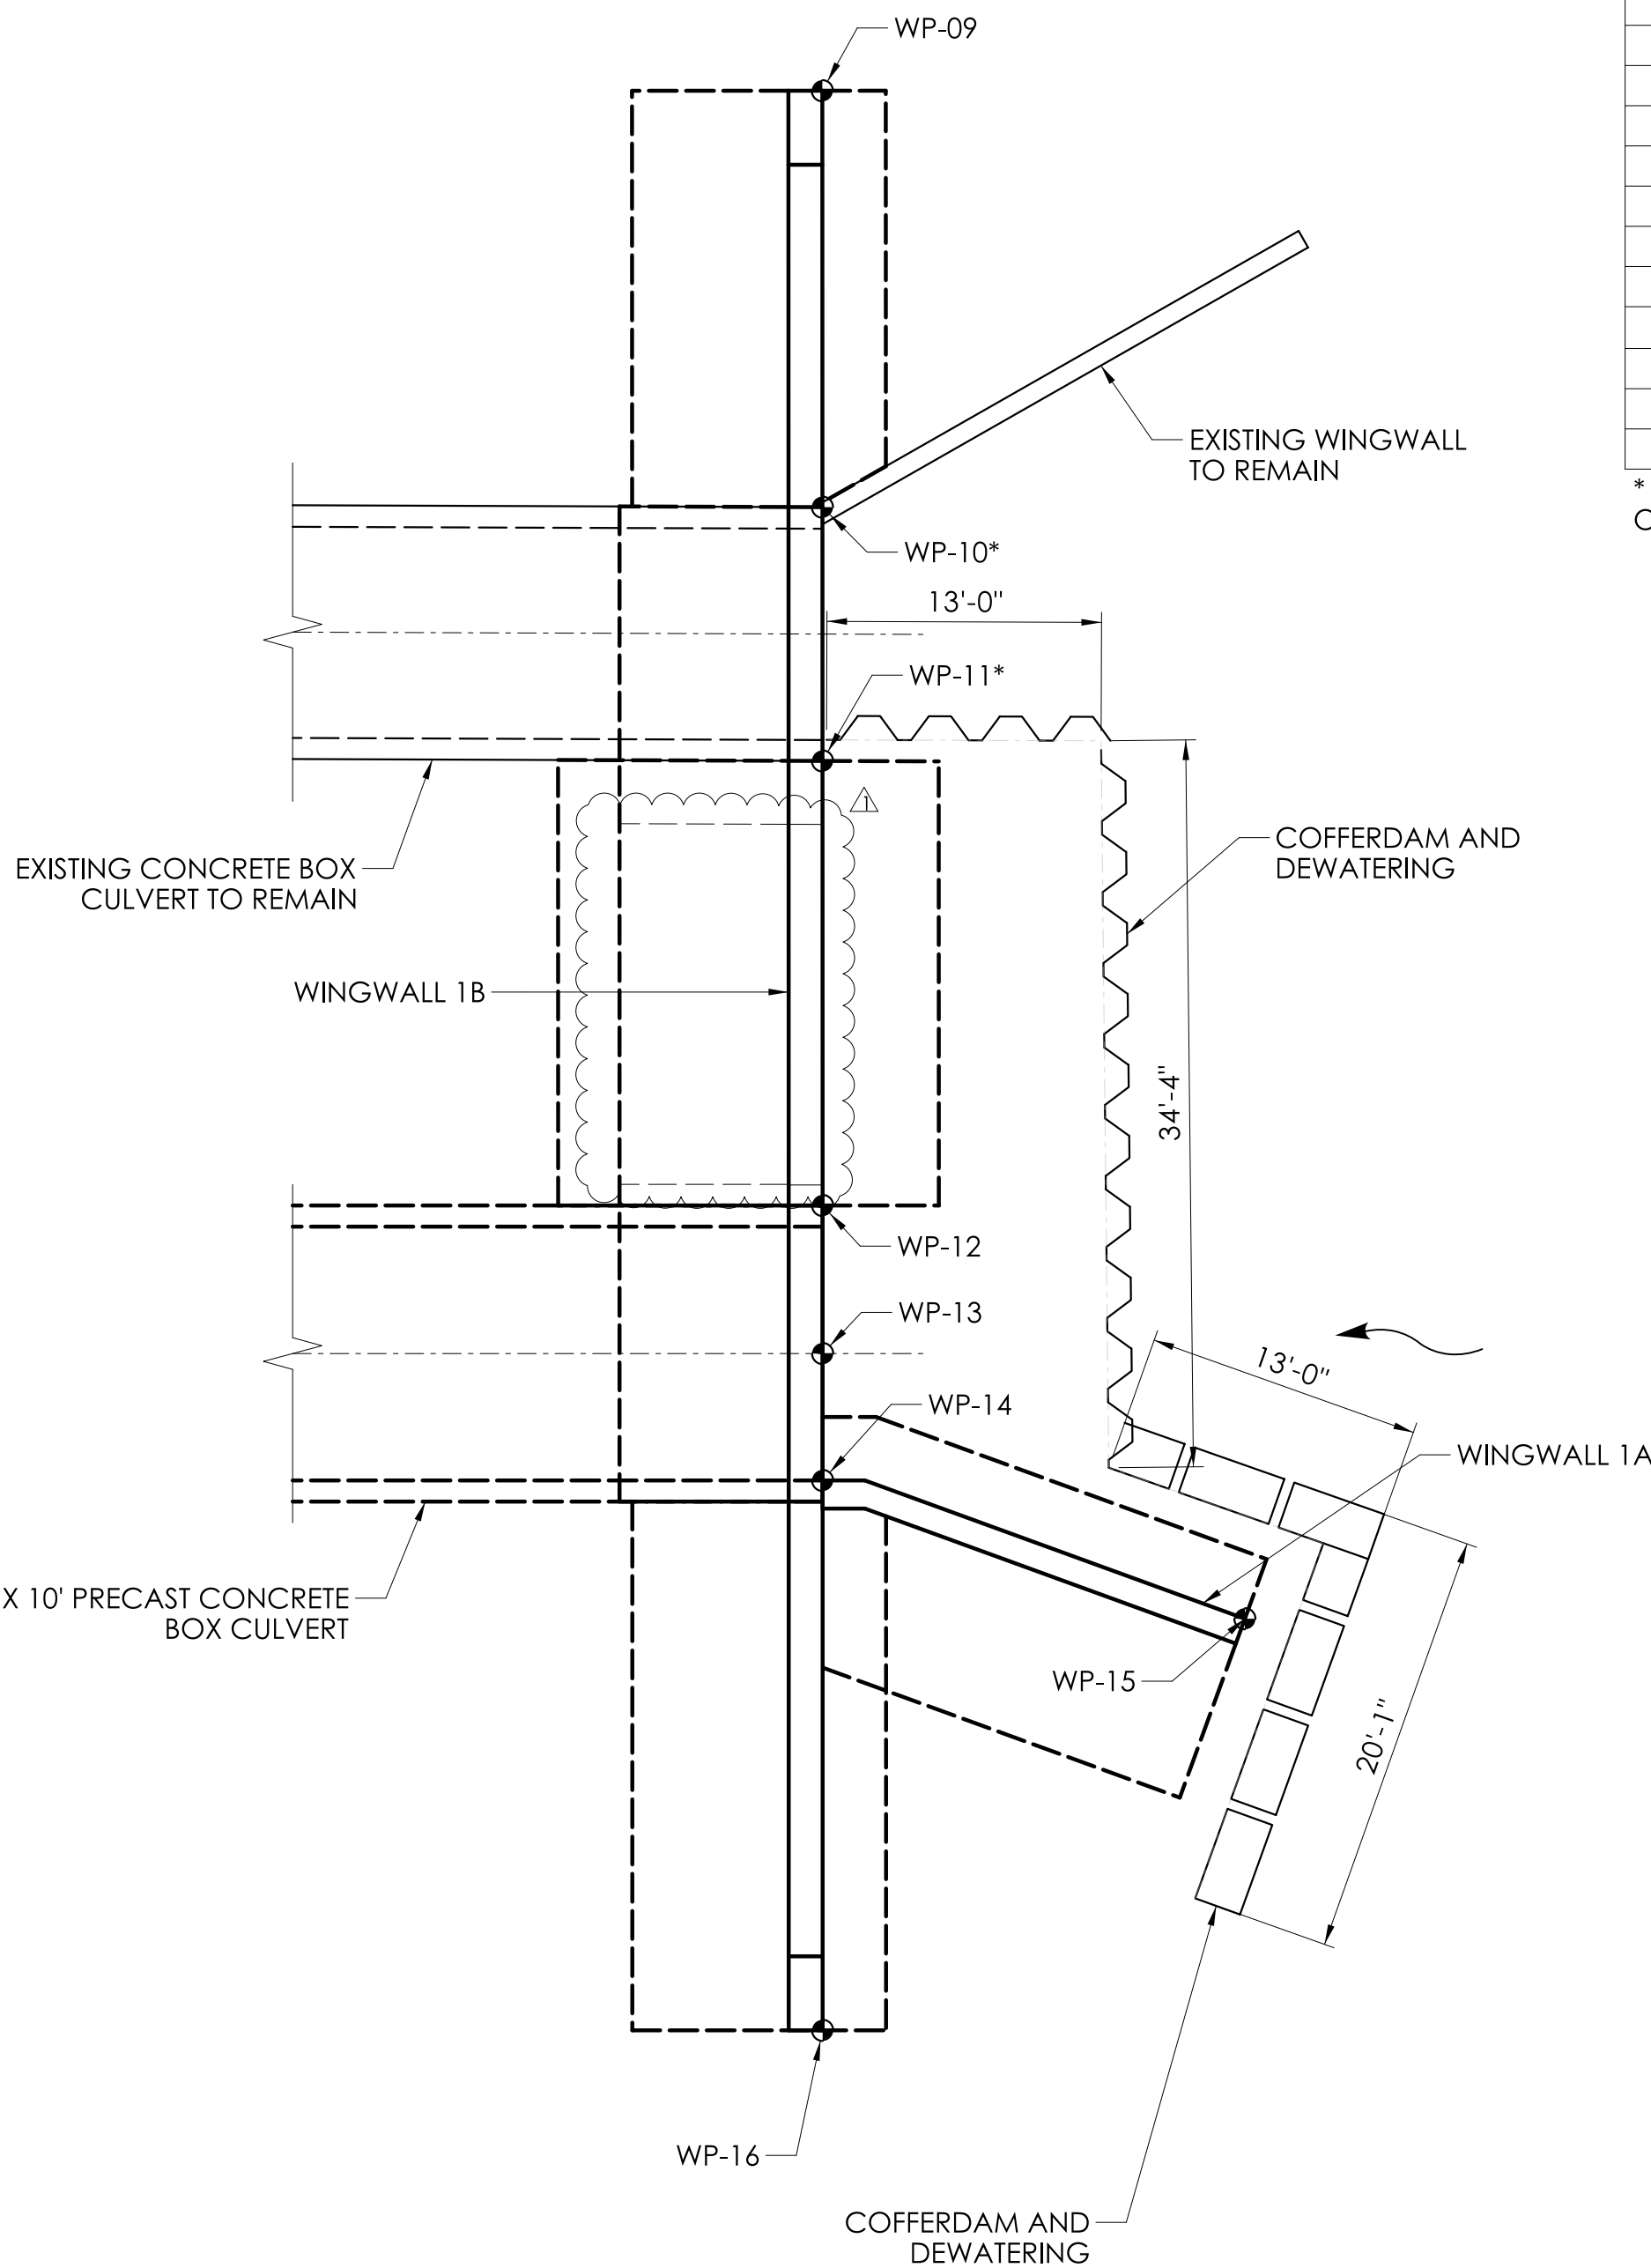

WORKING POINTS

WORKING POINT	NORTHING	EASTING	DESCRIPTION
WP-01	927702.145	1044651.732	NORTHWEST BARRIER WALL
WP-02*	927662.596	1044656.105	NORTHWEST CORNER - EXISTING CULVERT
WP-03*	927650.668	1044657.424	SOUTHWEST CORNER - EXISTING CULVERT
WP-04	927629.352	1044659.761	BEGIN WINGWALL 2B
WP-05	927622.394	1044660.531	CL CULVERT WEST END
WP-06	927615.437	1044661.300	BEGIN WINGWALL 2A
WP-07	927607.896	1044645.532	END WINGWALL 2A
WP-08	927597.546	1044663.279	SOUTHWEST BARRIER WALL
WP-09	927694.591	1044770.186	NORTHEAST BARRIER WALL
WP-10*	927675.022	1044772.355	NORTHEAST CORNER - EXISTING CULVERT
WP-11*	927663.095	1044773.677	SOUTHEAST CORNER - EXISTING CULVERT
WP-12	927642.205	1044775.992	BEGIN WINGWALL 1B
WP-13	927635.247	1044776.762	CL CULVERT EAST END
WP-14	927628.289	1044777.531	BEGIN WINGWALL 1A
WP-15	927624.978	1044797.987	END WINGWALL 1A
WP-16	927603.441	1044780.279	SOUTHEAST BARRIER WALL

* APPROXIMATE NORTHING AND EASTING PROVIDED. WORKING POINTS COINCIDE WITH THE ENDS OF EXISTING BOX CULVERT.

NOTE:

DIMENSIONS SHOWN ARE APPROXIMATE INTERIOR CLEAR DIMENSIONS TO COFFERDAM.

ADDENDUM NO. 1

REV	DATE	REVISION DESCRIPTION
1	09/12/25	REVISED JOINT LOCATIONS

SIGNATURE BLOCK:

ADA

A.D.Cesare Associates, P.C.
695 Clinton Avenue
Bridgeport, CT 06604
203-358-2444
www.adcesarempc.com

DESIGNER/DRAFTER: JGV CHECKED BY: JVS

SCALE AS NOTED



CONNECTICUT
DEPARTMENT OF
TRANSPORTATION


PROJECT TITLE:
**REPLACEMENT OF BRIDGE NO. 05585 - INTERSTATE 91
OVER GRAPE BROOK**

TOWN(S):
ENFIELD

DRAWING TITLE:
LAYOUT PLAN


PROJECT NO.:
0048-0200

DRAWING NO.:
STR-04
SHEET NO.:
04.04.A1

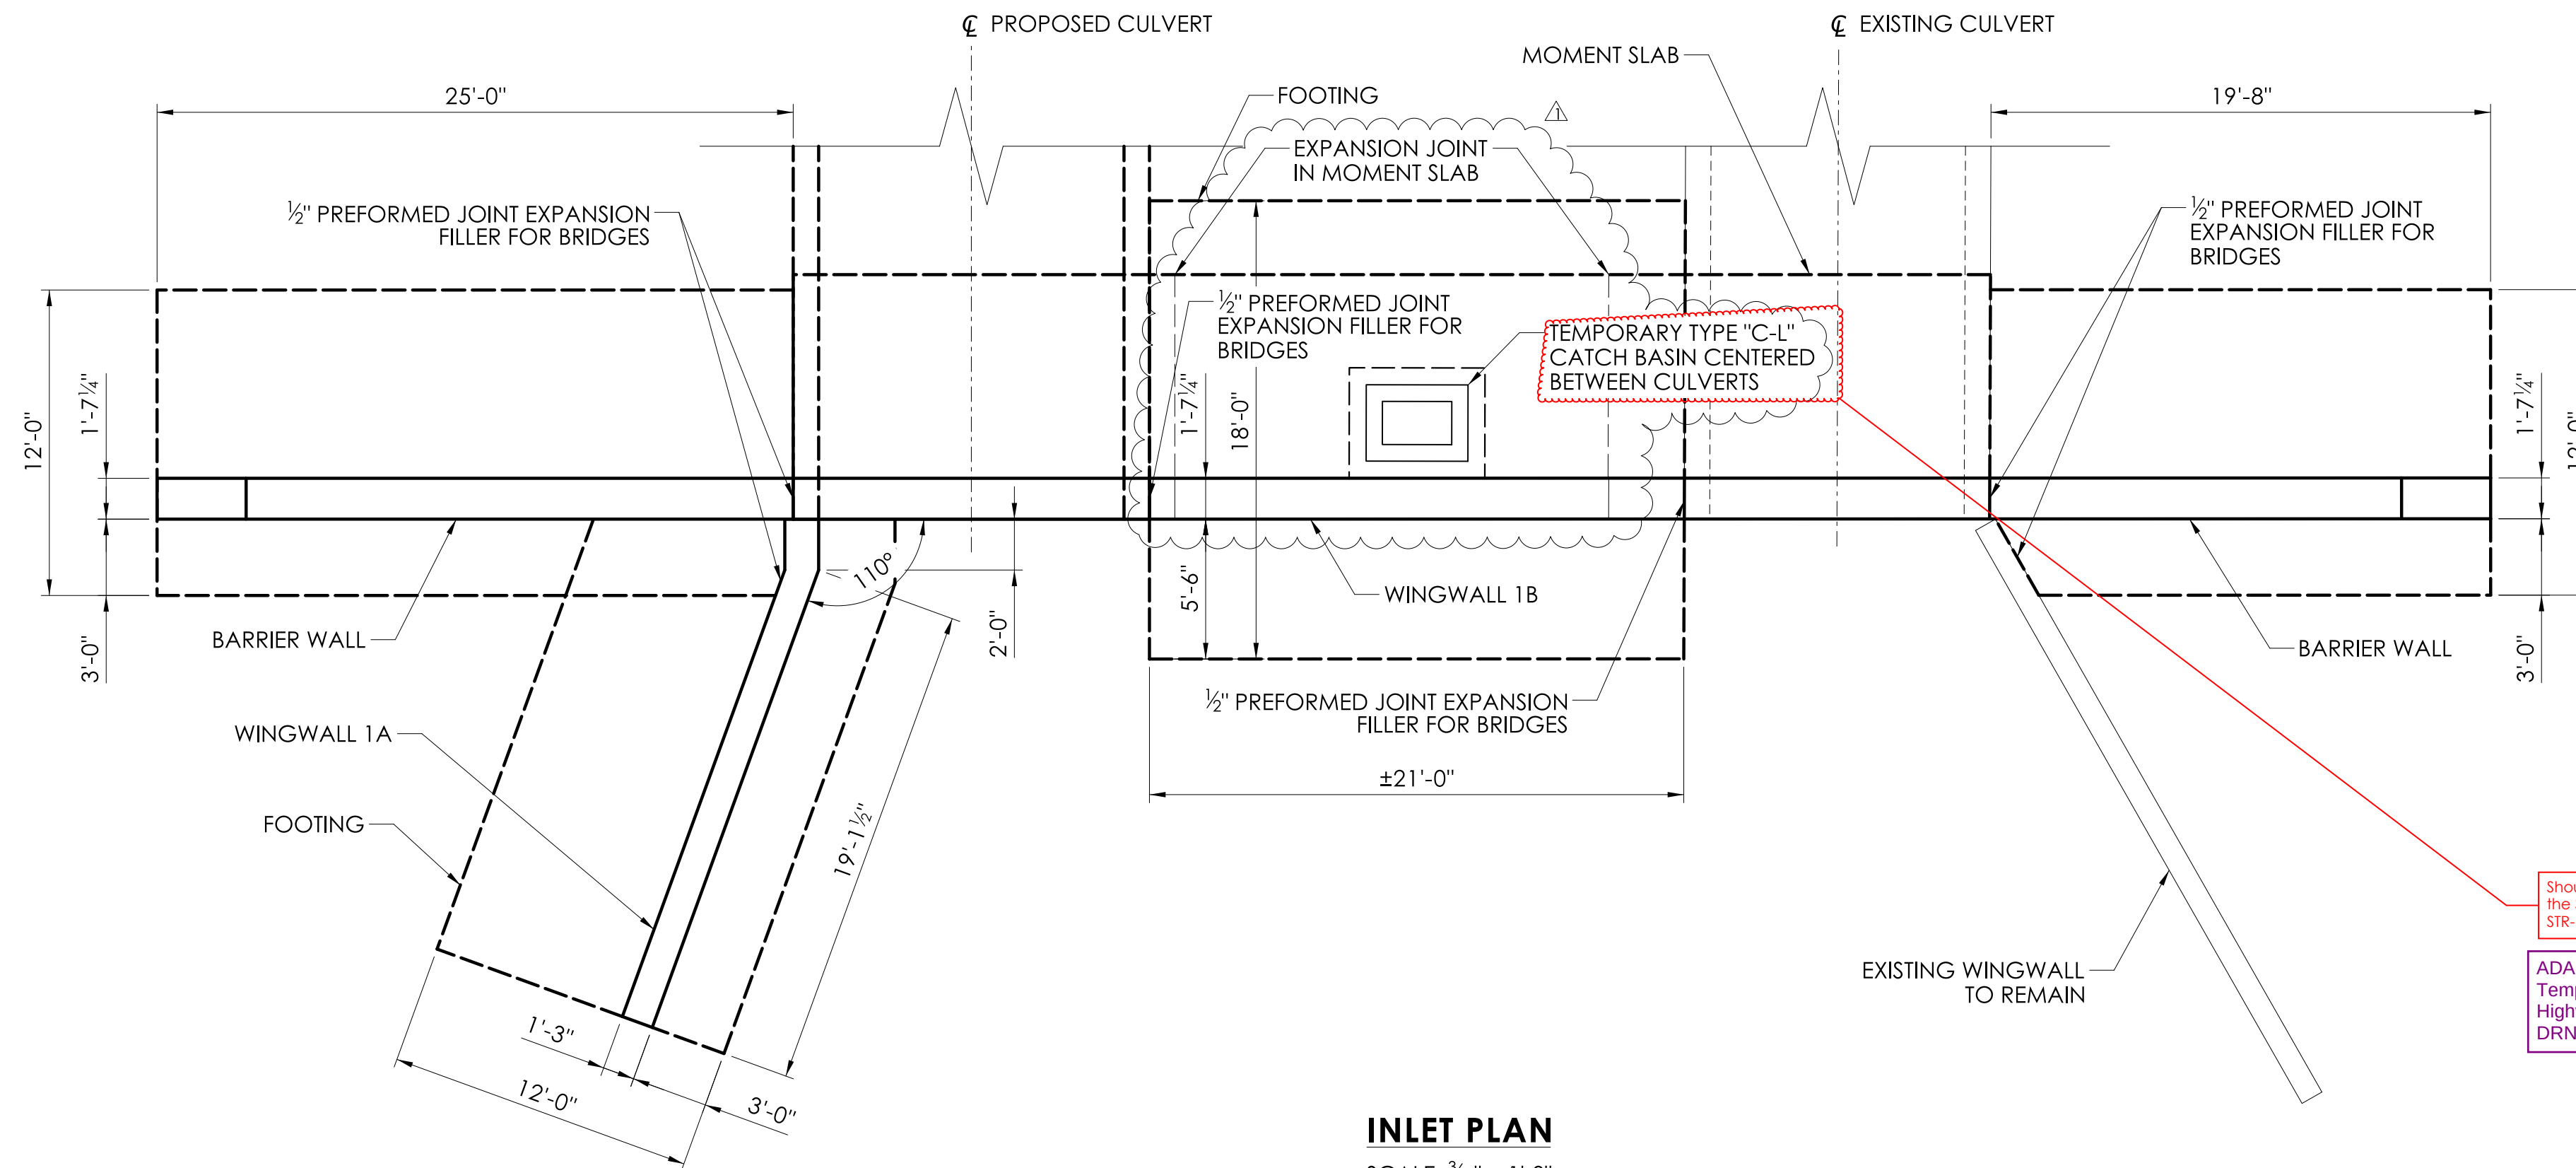

Should this CB be shown on the Stage Plans? STR-09, STR-10, and STR-11?

ADA Response:
Temporary drainage information can be found in the Highway subset. Revise referring to DRN-01 thru DRN-09-6 for the temporary drainage layout.

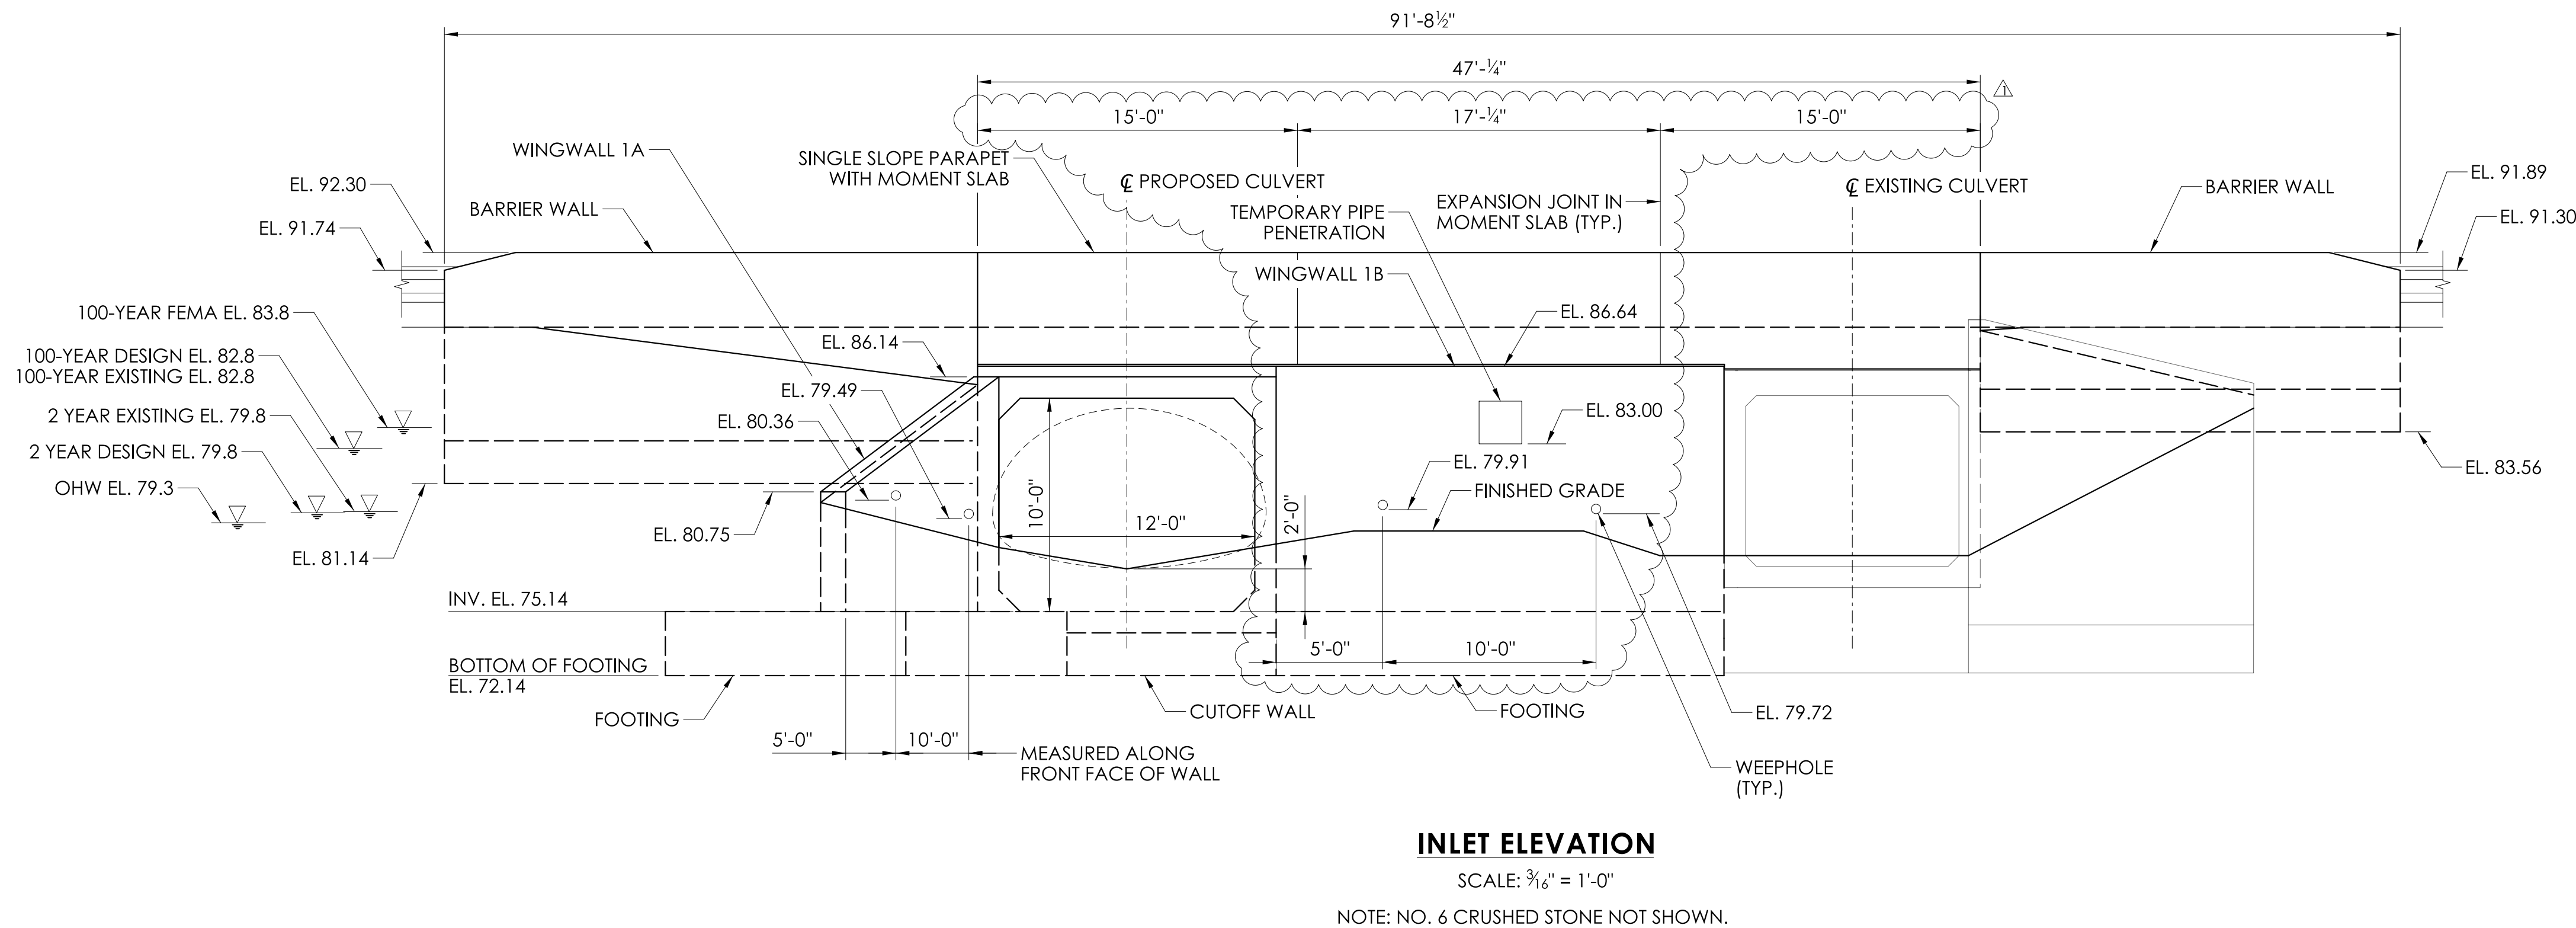


REV	DATE	REVISION DESCRIPTION
1	09/17/25	ADD TEMPORARY DRAINAGE STRUCTURES

SIGNATURE BLOCK:

A.DiCesare Associates, P.C.
695 Clinton Avenue
Bridgeport, CT 06604
203-338-2444
www.adidcesarepc.com

DESIGNER/DRAFTER: JGV
CHECKED BY: JVS

SCALE AS NOTED

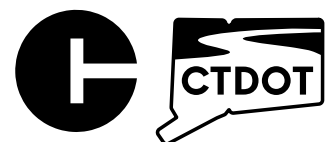

CONNECTICUT
DEPARTMENT OF
TRANSPORTATION

PROJECT TITLE:
**REPLACEMENT OF BRIDGE NO. 05585 - INTERSTATE 91
OVER GRAPE BROOK**

TOWN(S):
ENFIELD

DRAWING TITLE:
INLET LAYOUT

ADDENDUM NO. 1

PROJECT NO.: 0048-0200	DRAWING NO.: STR-12
	SHEET NO.: 04.12.A1

REV.	DATE	REVISION DESCRIPTION
09/17/25		ADD TEMPORARY DRAINAGE STRUCTURES

SIGNATURE BLOCK:

ADA

A.D.Cesare Associates, P.C.
695 Clinton Avenue
Bridgeport, CT 06604
203-368-2444
www.adacesarepc.com



DESIGNER/DRAFTER: JGV CHECKED BY: JVS

SCALE AS NOTED



CONNECTICUT
DEPARTMENT OF
TRANSPORTATION





PROJECT TITLE:
**REPLACEMENT OF BRIDGE NO. 05585 - INTERSTATE 91
OVER GRAPE BROOK**

TOWN(S):
ENFIELD

DRAWING TITLE:
OUTLET LAYOUT

PROJECT NO.:
0048-0200

DRAWING NO.:
STR-13
SHEET NO.:
04.13.A1

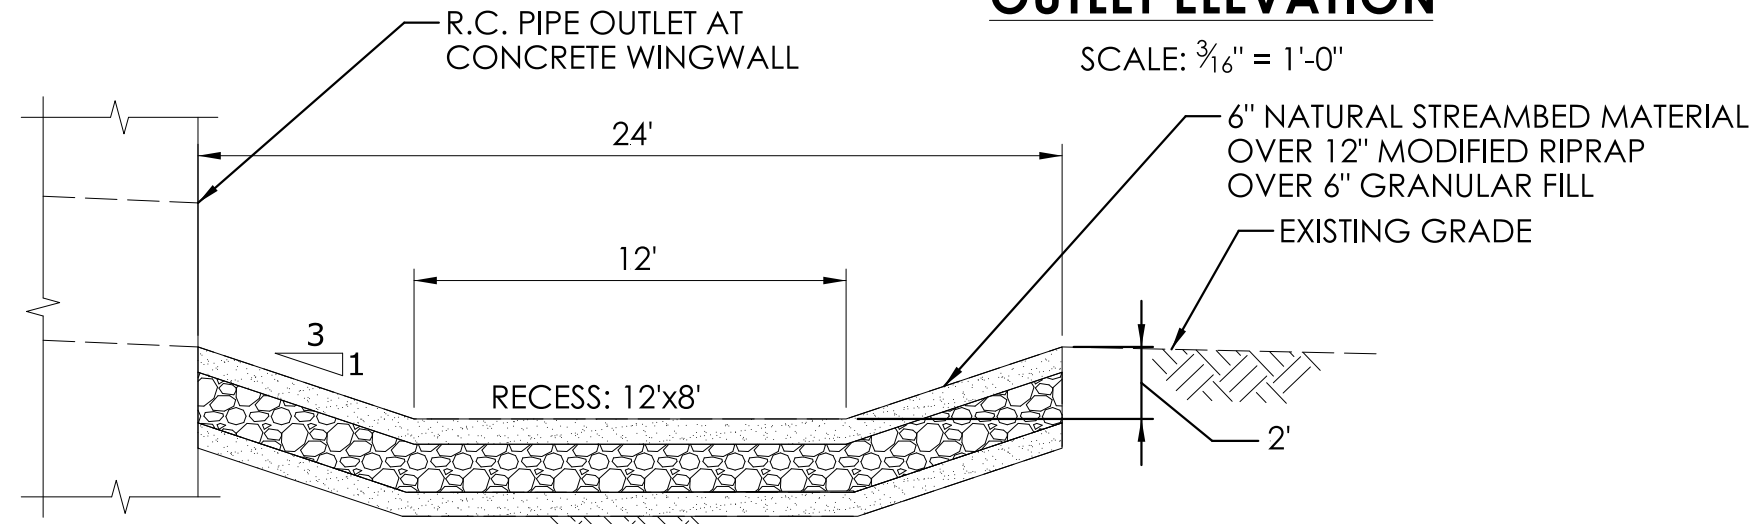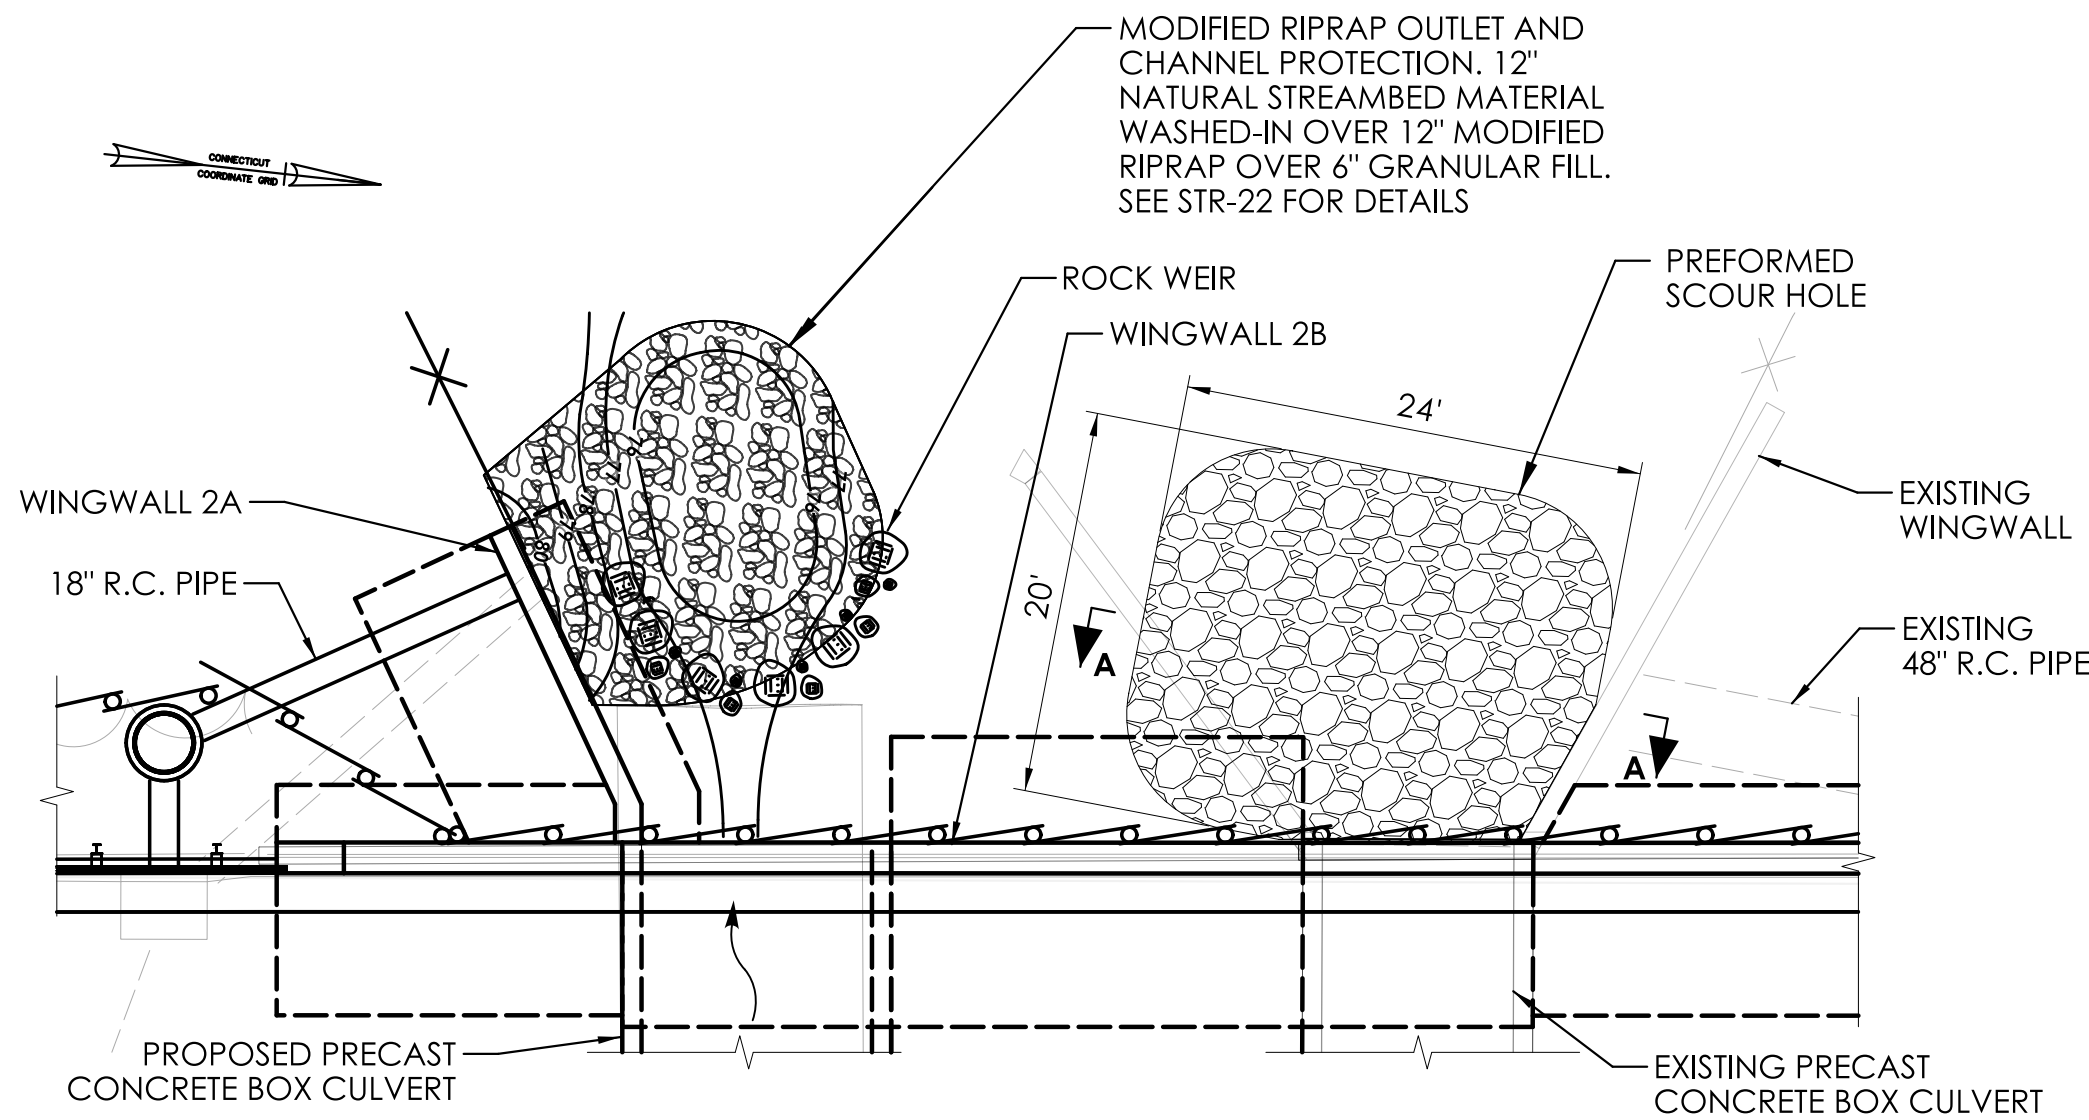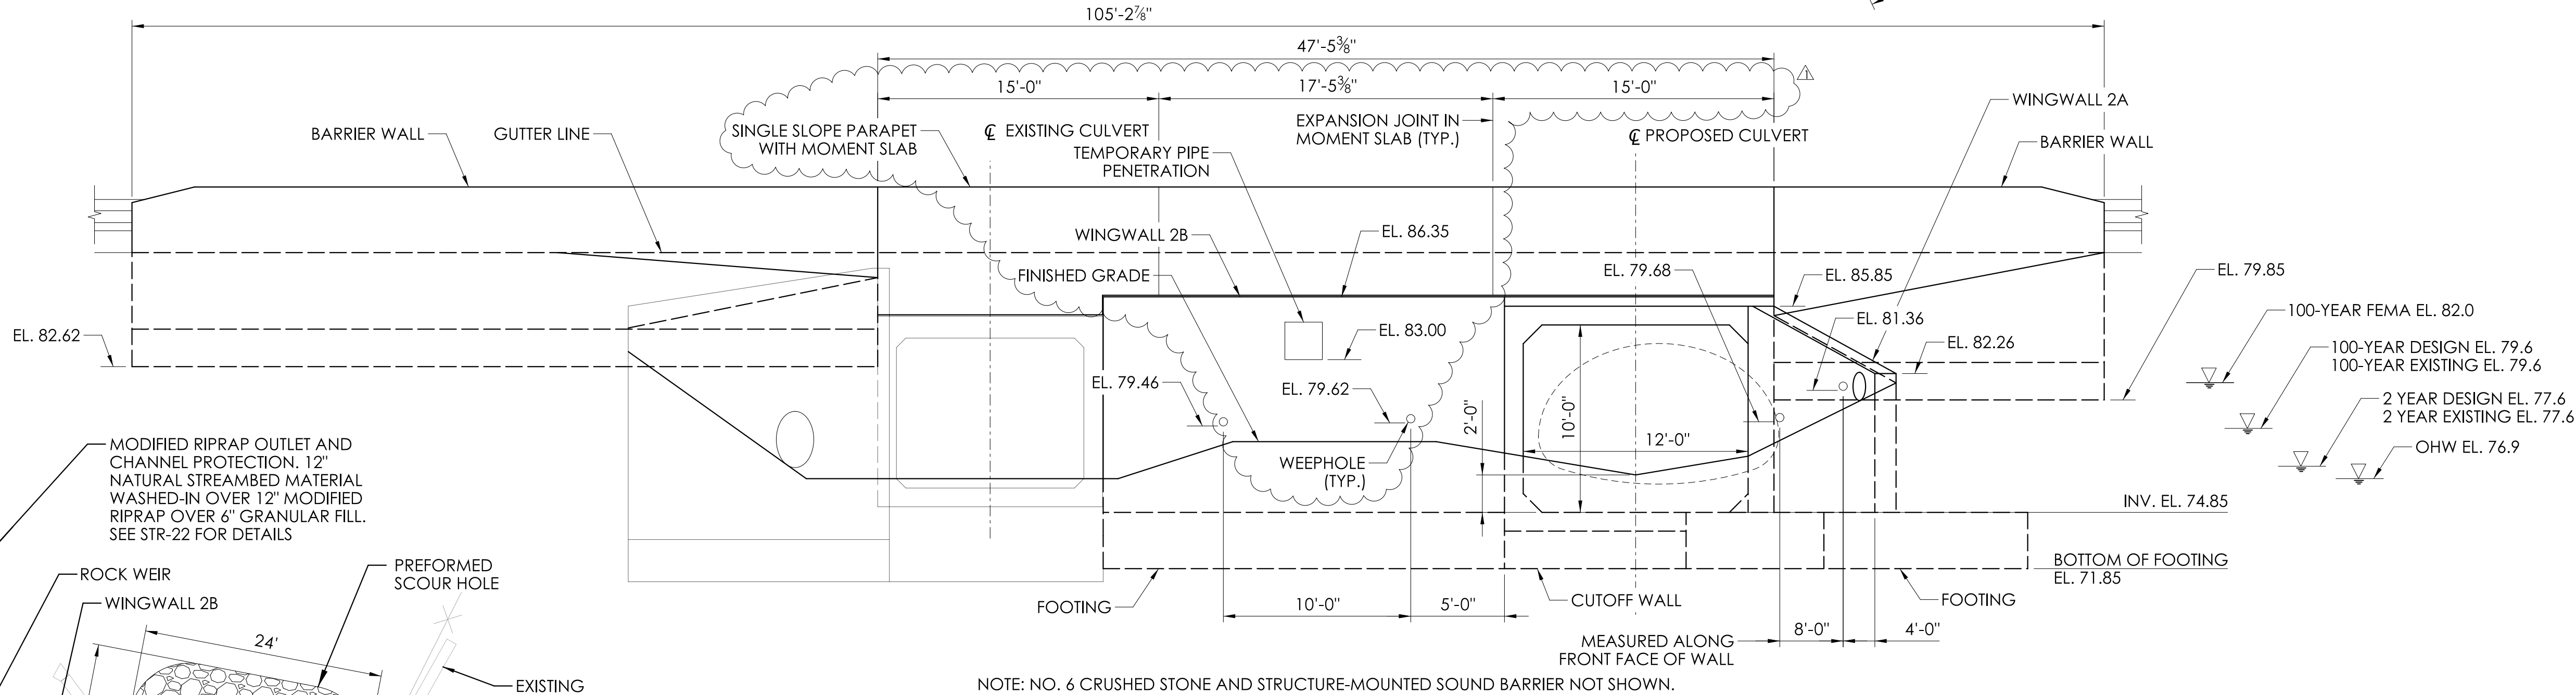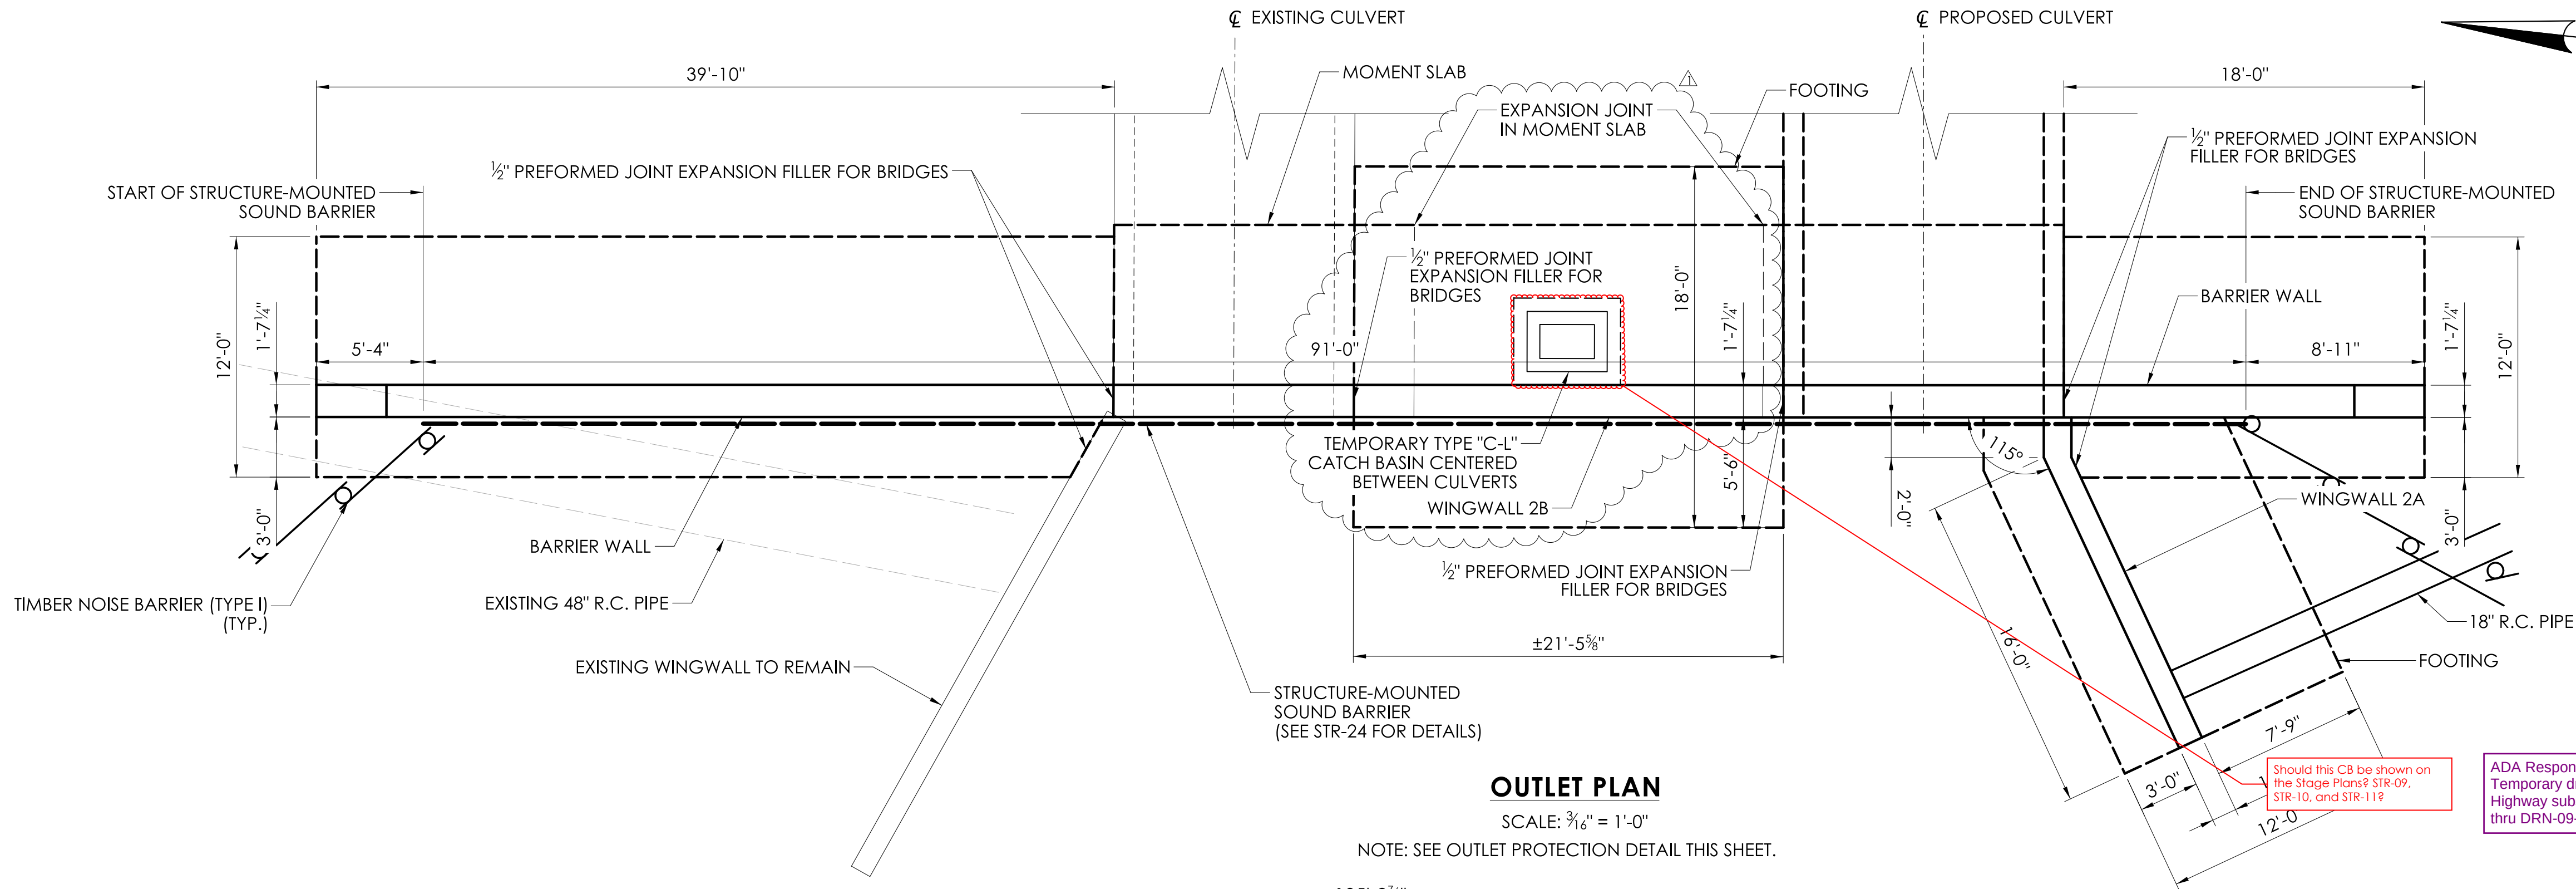

ADDENDUM NO. 1

REV.	DATE	REVISION DESCRIPTION

- NOTES:
- DOWEL BAR SPICER INSERTS SHALL BE PAID FOR UNDER ITEM "DOWEL BAR SPICER SYSTEM GALVANIZED".
 - 1/2" PREFORMED EXPANSION JOINT FILLER FOR BRIDGES PLACED BETWEEN THE TEMPORARY CATCH BASIN AND MOMENT SLAB SHALL BE PAID FOR UNDER ITEM "TEMPORARY DRAINAGE SYSTEM".

SIGNATURE BLOCK:

ADA

A.Dicciare Associates, P.C.
695 Clinton Avenue
Bridgeport, CT 06604
203-368-2444
www.adassociatespc.com



DESIGNER/DRAFTER: JGV CHECKED BY: JVS

SCALE AS NOTED



CONNECTICUT
DEPARTMENT OF
TRANSPORTATION

PROJECT TITLE:
**REPLACEMENT OF BRIDGE NO. 05585 - INTERSTATE 91
OVER GRAPE BROOK**

TOWN(S):
ENFIELD

DRAWING TITLE:
WALL DETAILS - 3

NEW SHEET ADDED BY
ADDENDUM NO. 1

PROJECT NO.:
0048-0200

DRAWING NO.:
STR-15-1

SHEET NO.:
04.15-1.A1

